


DRAWING NOTES: (F)
1. DOOR POSITION SWITCH IN WALL SYSTEM
BY ELECTRONIC SECURITY VENDOR CONTRACTOR.

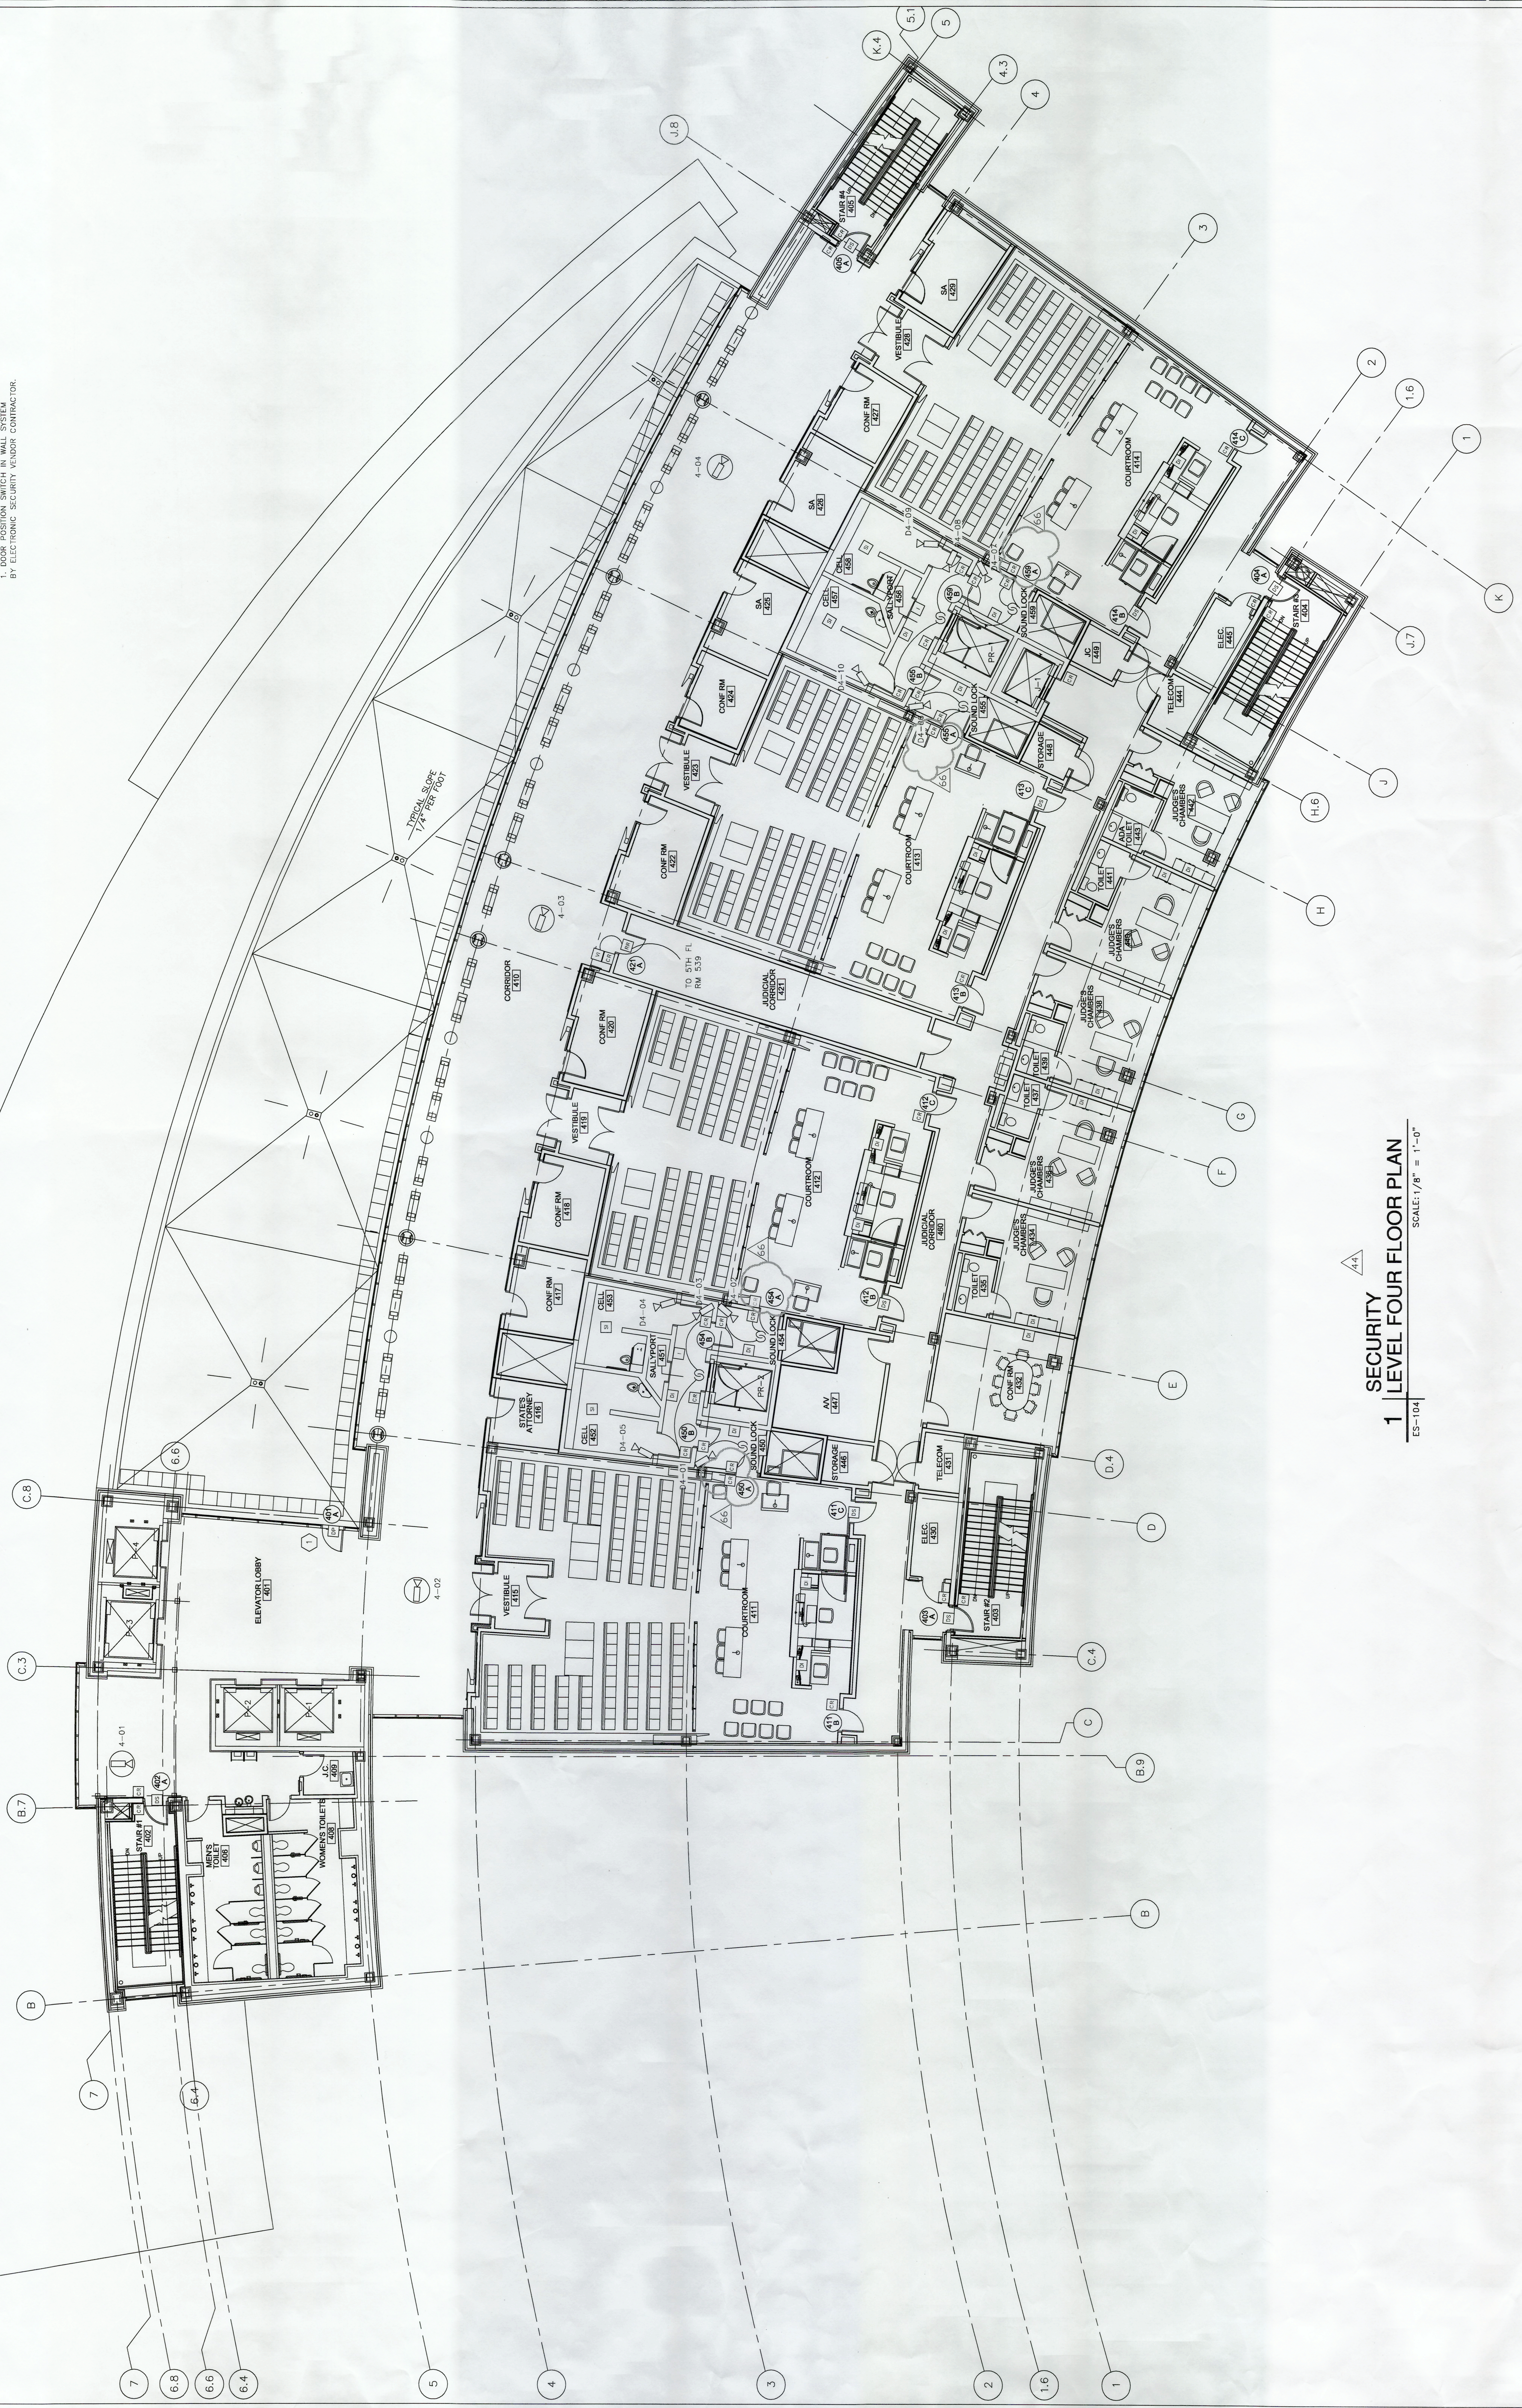

SECURITY LEVEL FOUR FLOOR PLAN
1 LEVEL FOUR FLOOR PLAN
ES-104 SCALE: 1/8" = 1'-0"